

Project Name and Address  
**MONTGOMERY CITY MIDDLE SCHOOL**  
 418 N HWY 19  
 MONTGOMERY CITY, MO 63561  
 573-564-2278

Title  
**INTERCOM PARTIAL FLOOR PLAN**

Project # 17882 Dwg. By EJM Chk. By  
 Date 3-12-2015 Sheet  
 Scale 1/16" = 10' IC-1

5		
4		
3		
2		
1		
No.	Revision/Issue	Date

General Notes

SPEAKERS SHOWN ARE NOT IN EXACT LOCATIONS. VERIFY WITH OWNER BEFORE INSTALLING. CABLE ROUTING MAY VARY. CABLE SHOWN IS FOR ILLUSTRATIVE PURPOSES ONLY.


SYMBOL LEGEND		
SYMBOL	DESCRIPTION	PART NUMBER
⊙	CEILING MOUNTED	BAFKIT2X2LVC
⊞	WALL MOUNTED	ACCWB5
⊞	OUTDOOR	ACC1412
⊞	CONTROL UNIT	TCC2011
AMP	AMPLIFIER	PMM120A-1852

CABLE LEGEND		
LETTER	DESCRIPTION	
A	CAT5E	
B	18-4	
C	18-2	

MATCHLINE  
MATCHLINE

**All Systems**  
 Designed Solutions, Inc.  
 3241 North 7th Street Trafficway  
 Kansas City, KS 66115  
 913-281-5100 fax 913-281-5511

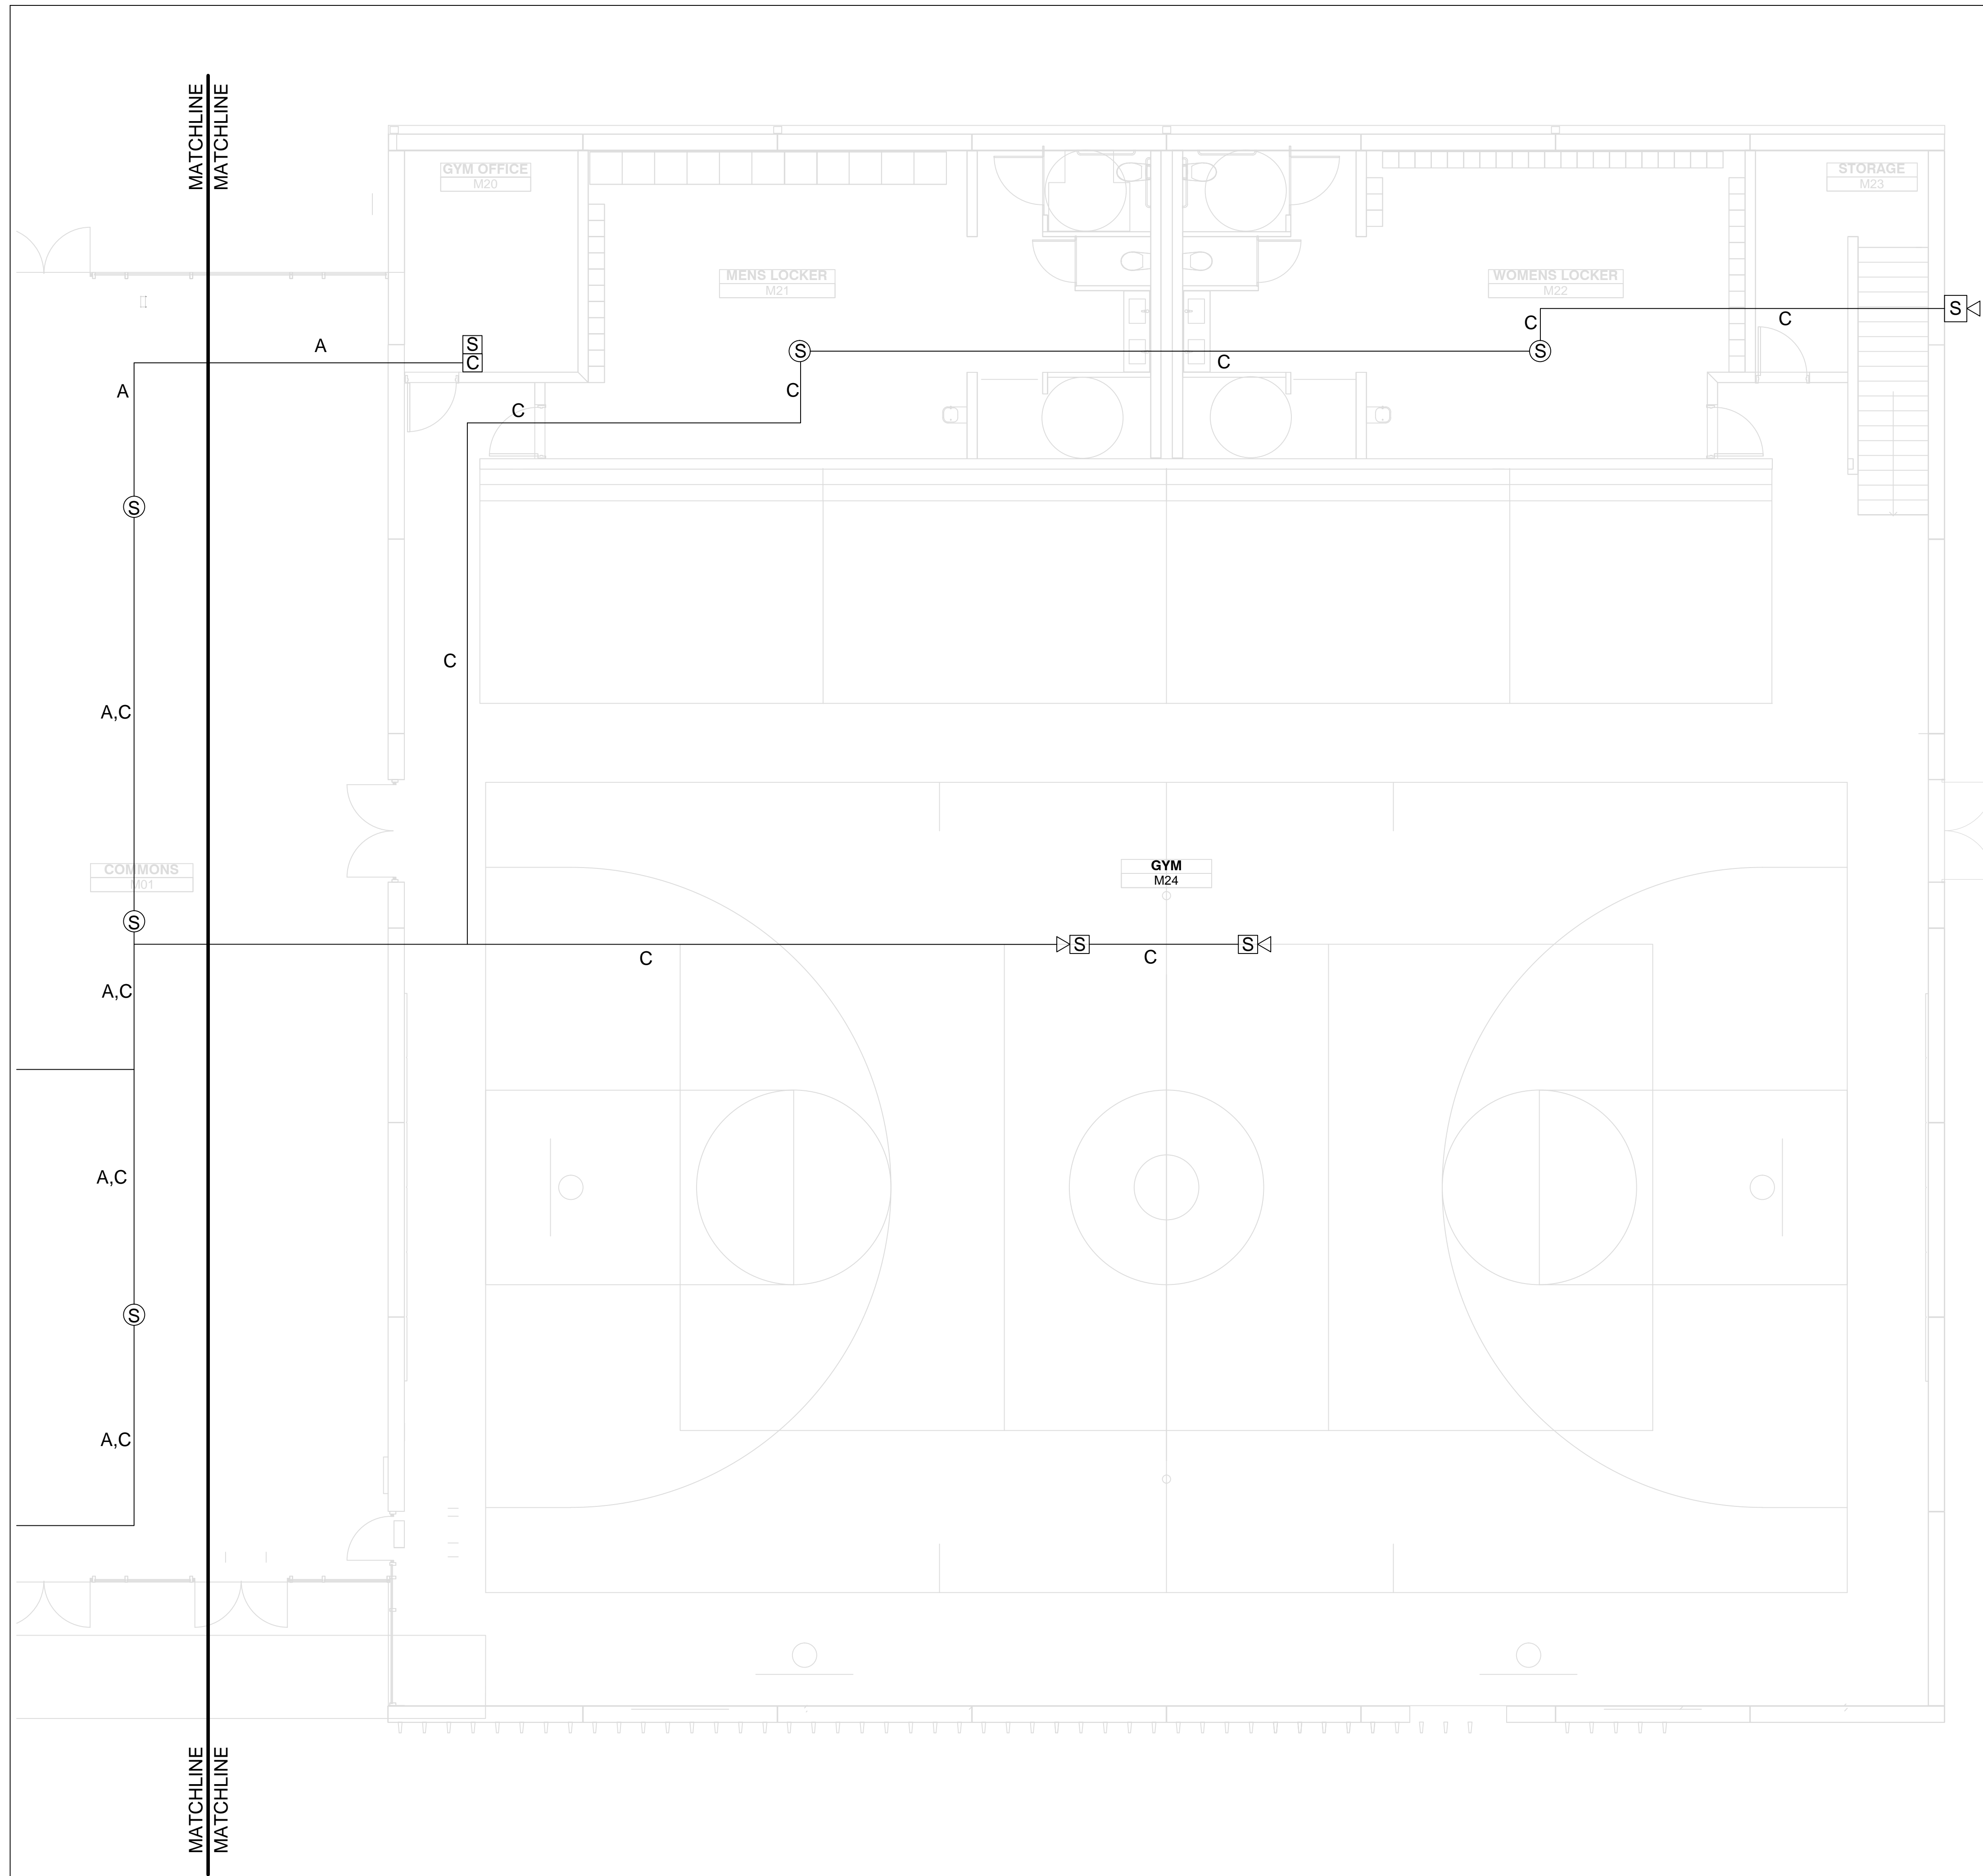

SYMBOL LEGEND		
SYMBOL	DESCRIPTION	PART NUMBER
⊙	CEILING MOUNTED	BAFKIT2X2LVC
⊞	WALL MOUNTED	ACCWB5
⊞	OUTDOOR	ACC1412
⊞	CONTROL UNIT	TCC2011
AMP	AMPLIFIER	PMM120A-1852

CABLE LEGEND		
A	CAT5E	
B	18-4	
C	18-2	

Project Name and Address  
**MONTGOMERY CITY MIDDLE SCHOOL**  
 418 N HWY 19  
 MONTGOMERY CITY, MO 63561  
 573-264-2218

Title  
**INTERCOM PARTIAL FLOOR PLAN**

Project # 17882 Dwg. By EJM Chk. By  
 Date 3-12-2015 Sheet  
 Scale 1/16" = 10' **10-2**

5		
4		
3		
2		
1		
No.	Revision/Issue	Date

General Notes


SPEAKERS SHOWN ARE NOT IN EXACT LOCATIONS. VERIFY WITH OWNER BEFORE INSTALLING

CABLE ROUTING MAY VARY. CABLE SHOWN IS FOR ILLUSTRATIVE PURPOSES ONLY.

**All Systems**  
 Designed Solutions, Inc.

3241 North 7th Street Trafficway  
 Kansas City, KS 66115  
 913-281-5100 fax 913-281-5511

P  
O  
E  
S  
W  
I  
T  
C  
H

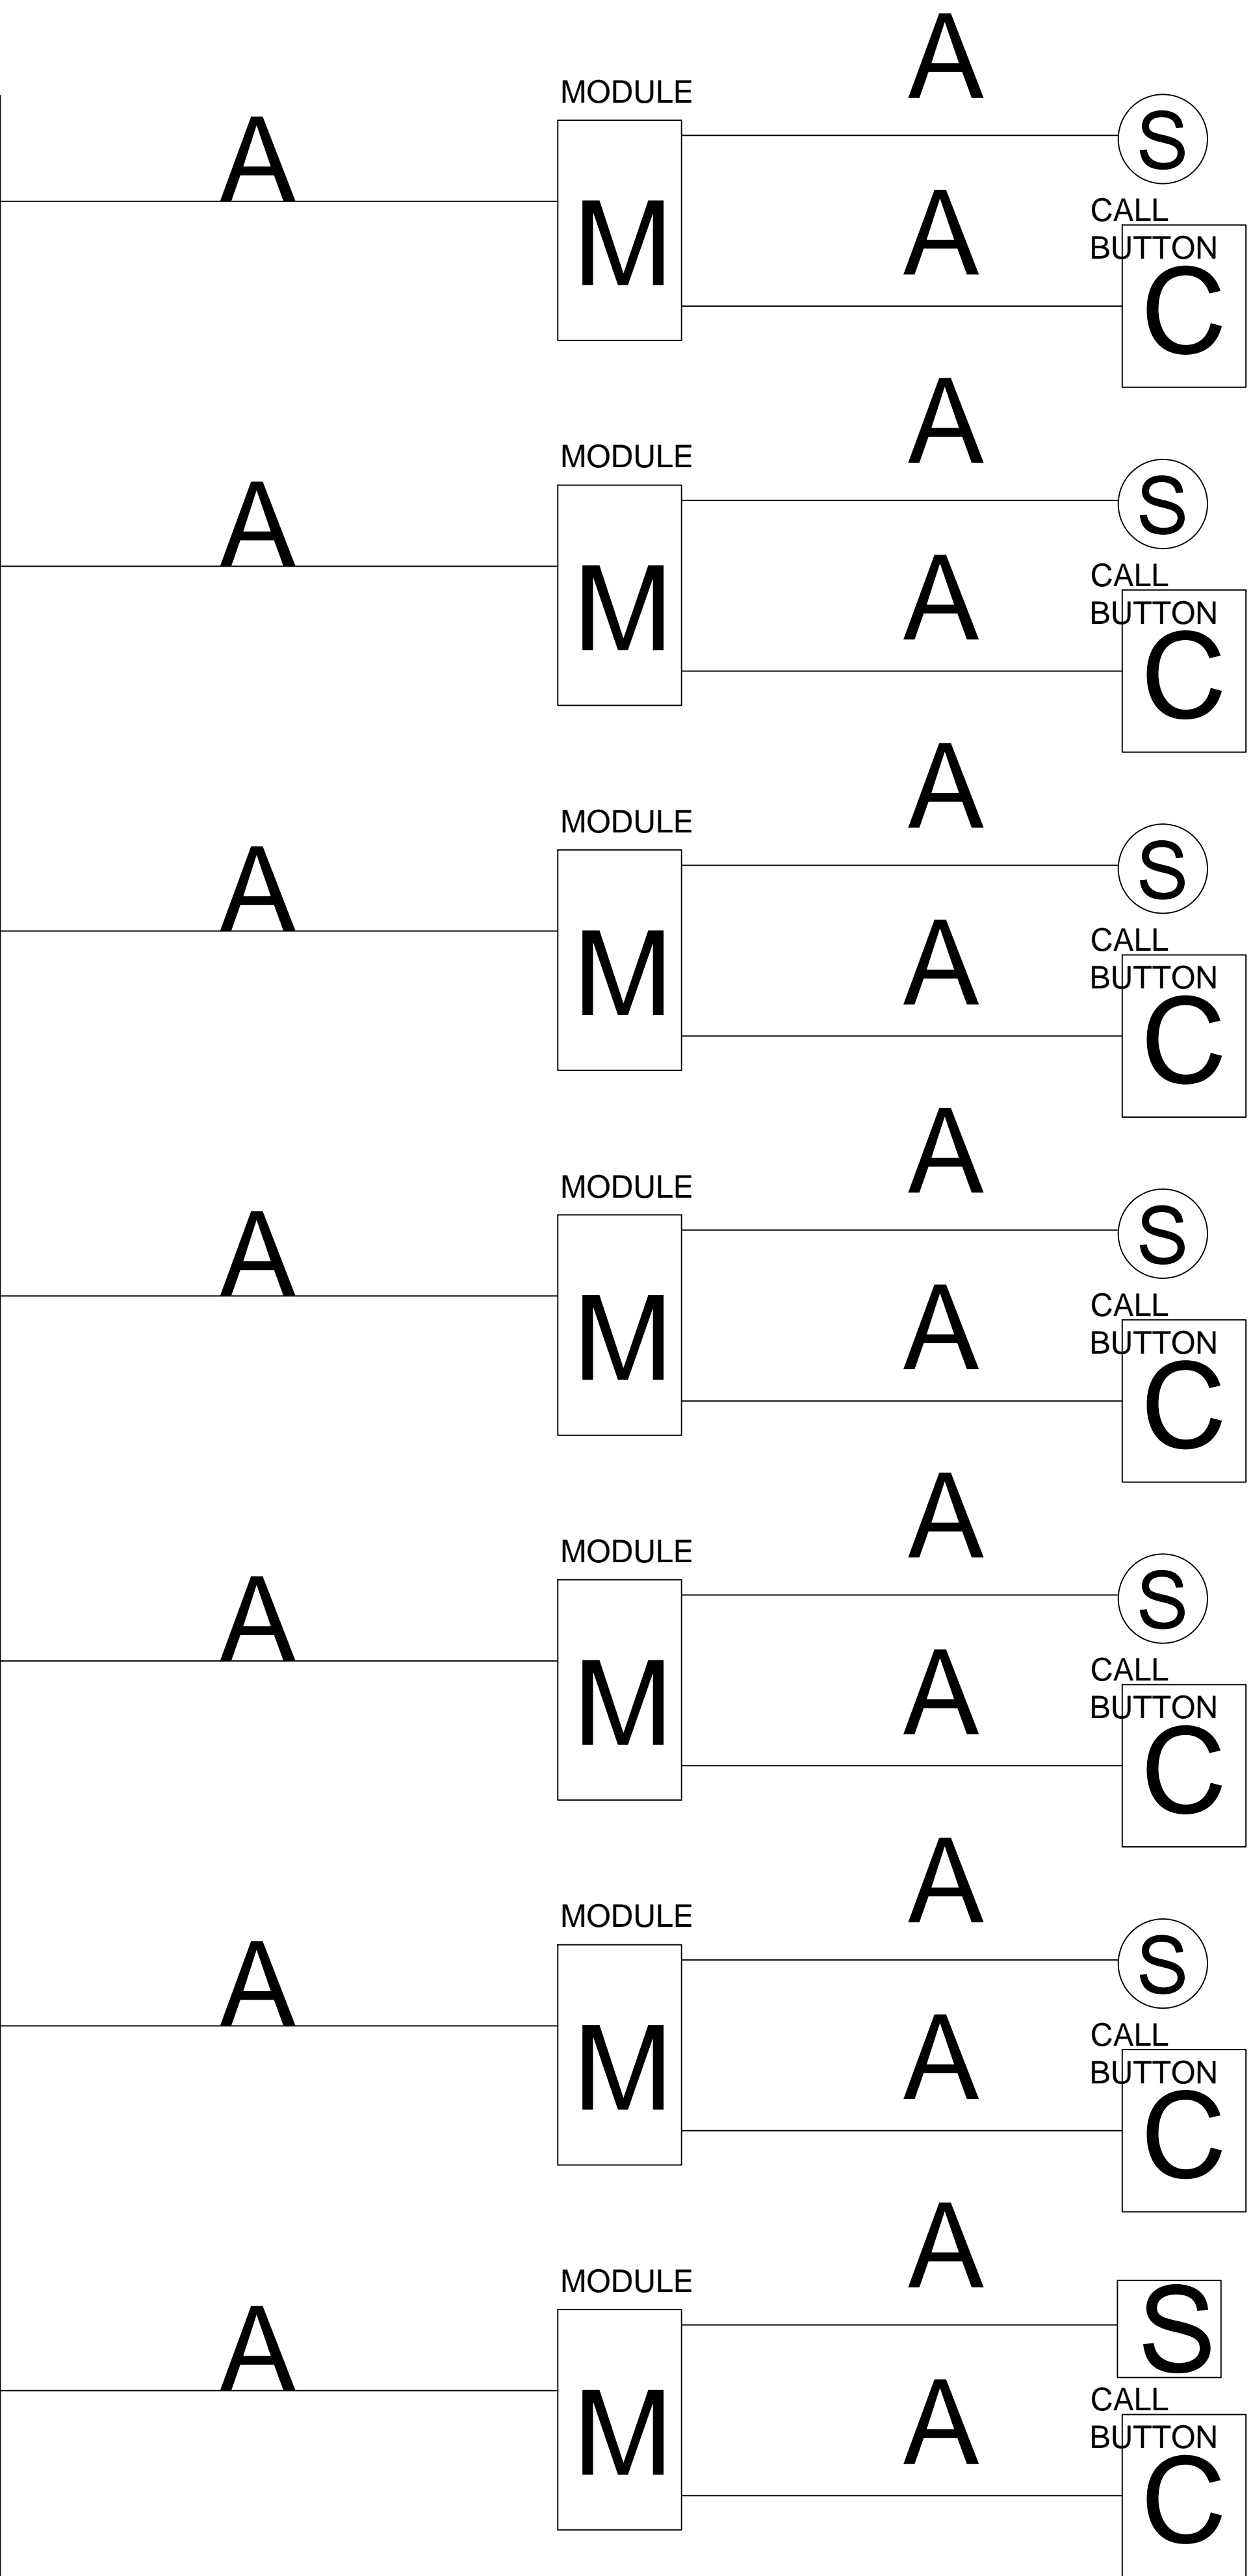

Project Name and Address  
**MONTGOMERY CITY  
 MIDDLE SCHOOL**  
 418 N HWY 19  
 MONTGOMERY CITY, MO 63561  
 573-564-2278

Title  
**CLASSROOM  
 ONE LINE**


Project # 17882 Dwg. By EJM Chk. By  
 Date 3-12-2015 Sheet  
 Scale NTS **OL-1**

5		
4		
3		
2		
1		
No.	Revision/Issue	Date

General Notes

**All Systems  
 Designed Solutions, Inc.**  
 3241 North 7th Street Trafficway  
 Kansas City, KS 66115  
 913-281-5100 fax 913-281-5511

# POWER SWITCH

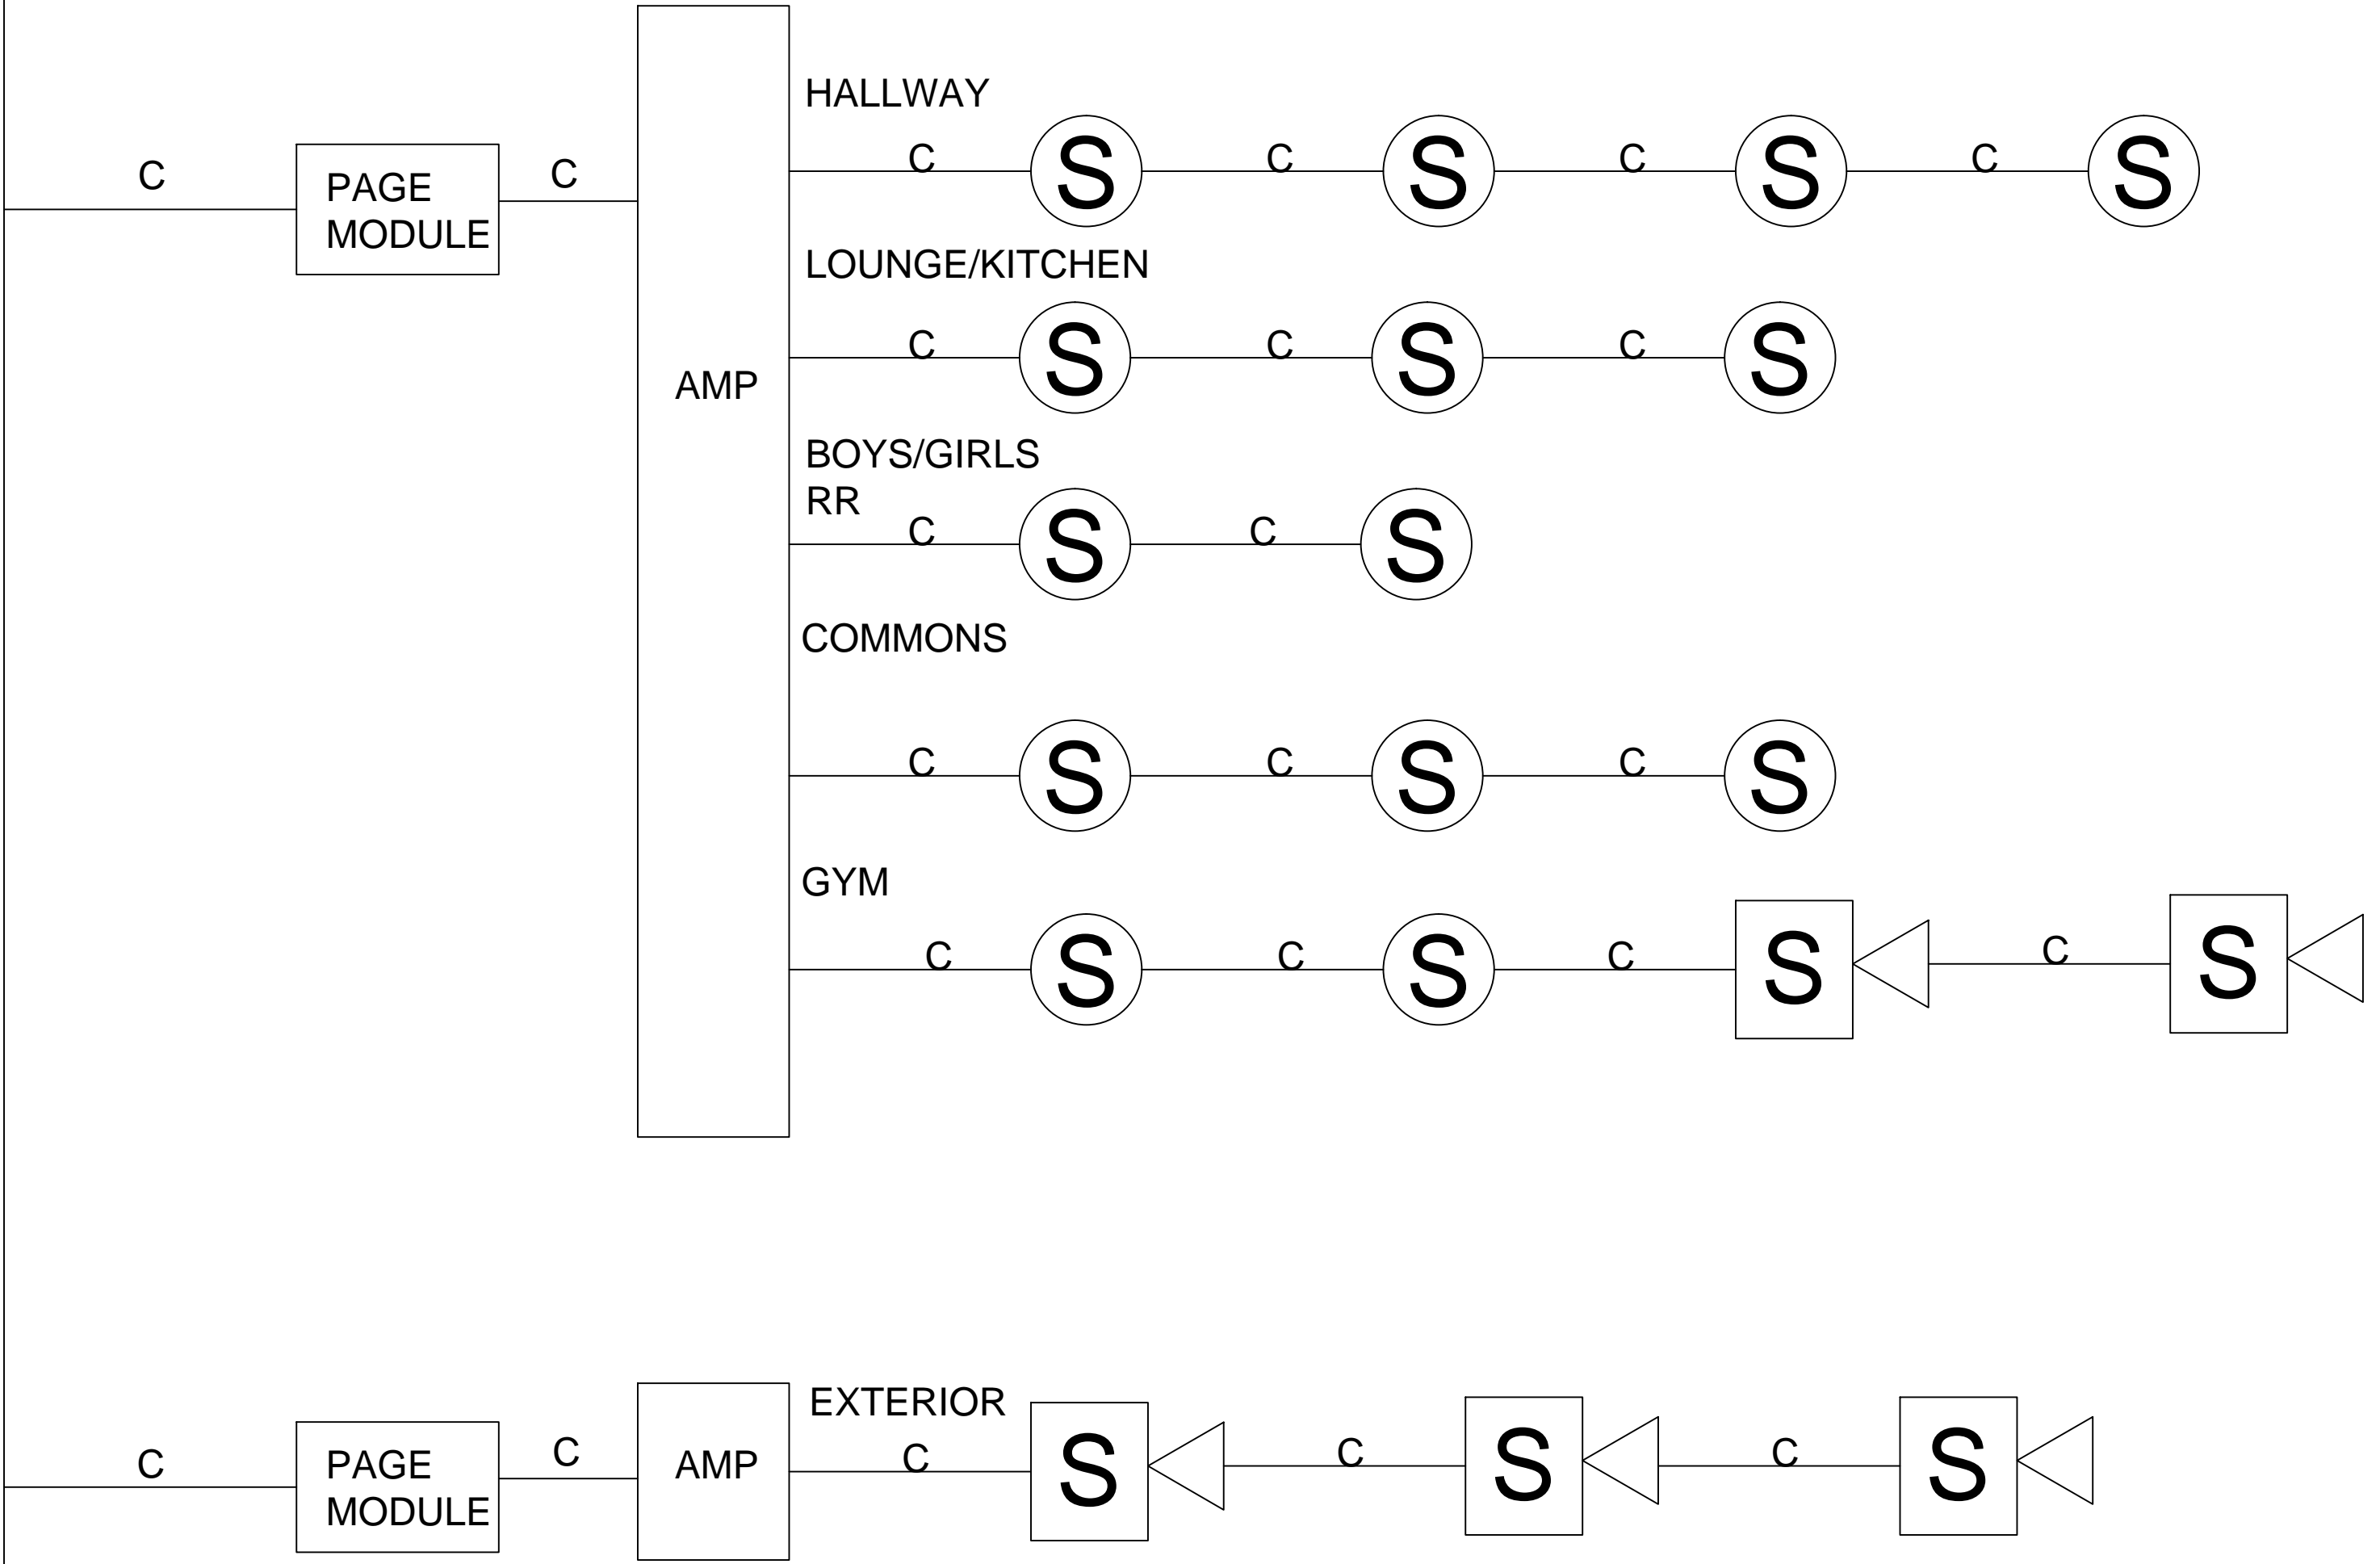

Project Name and Address  
**MONTGOMERY CITY MIDDLE SCHOOL**  
 418 N HWY 19  
 MONTGOMERY CITY, MO 63561  
 573-564-2278

Title  
**INTERCOM ONE LINE**

Project # 17882 Dwg. By EJM Chk. By  
 Date 3-12-2015 Sheet  
 Scale NTS **OL-2**

5		
4		
3		
2		
1		
No.	Revision/Issue	Date

General Notes